

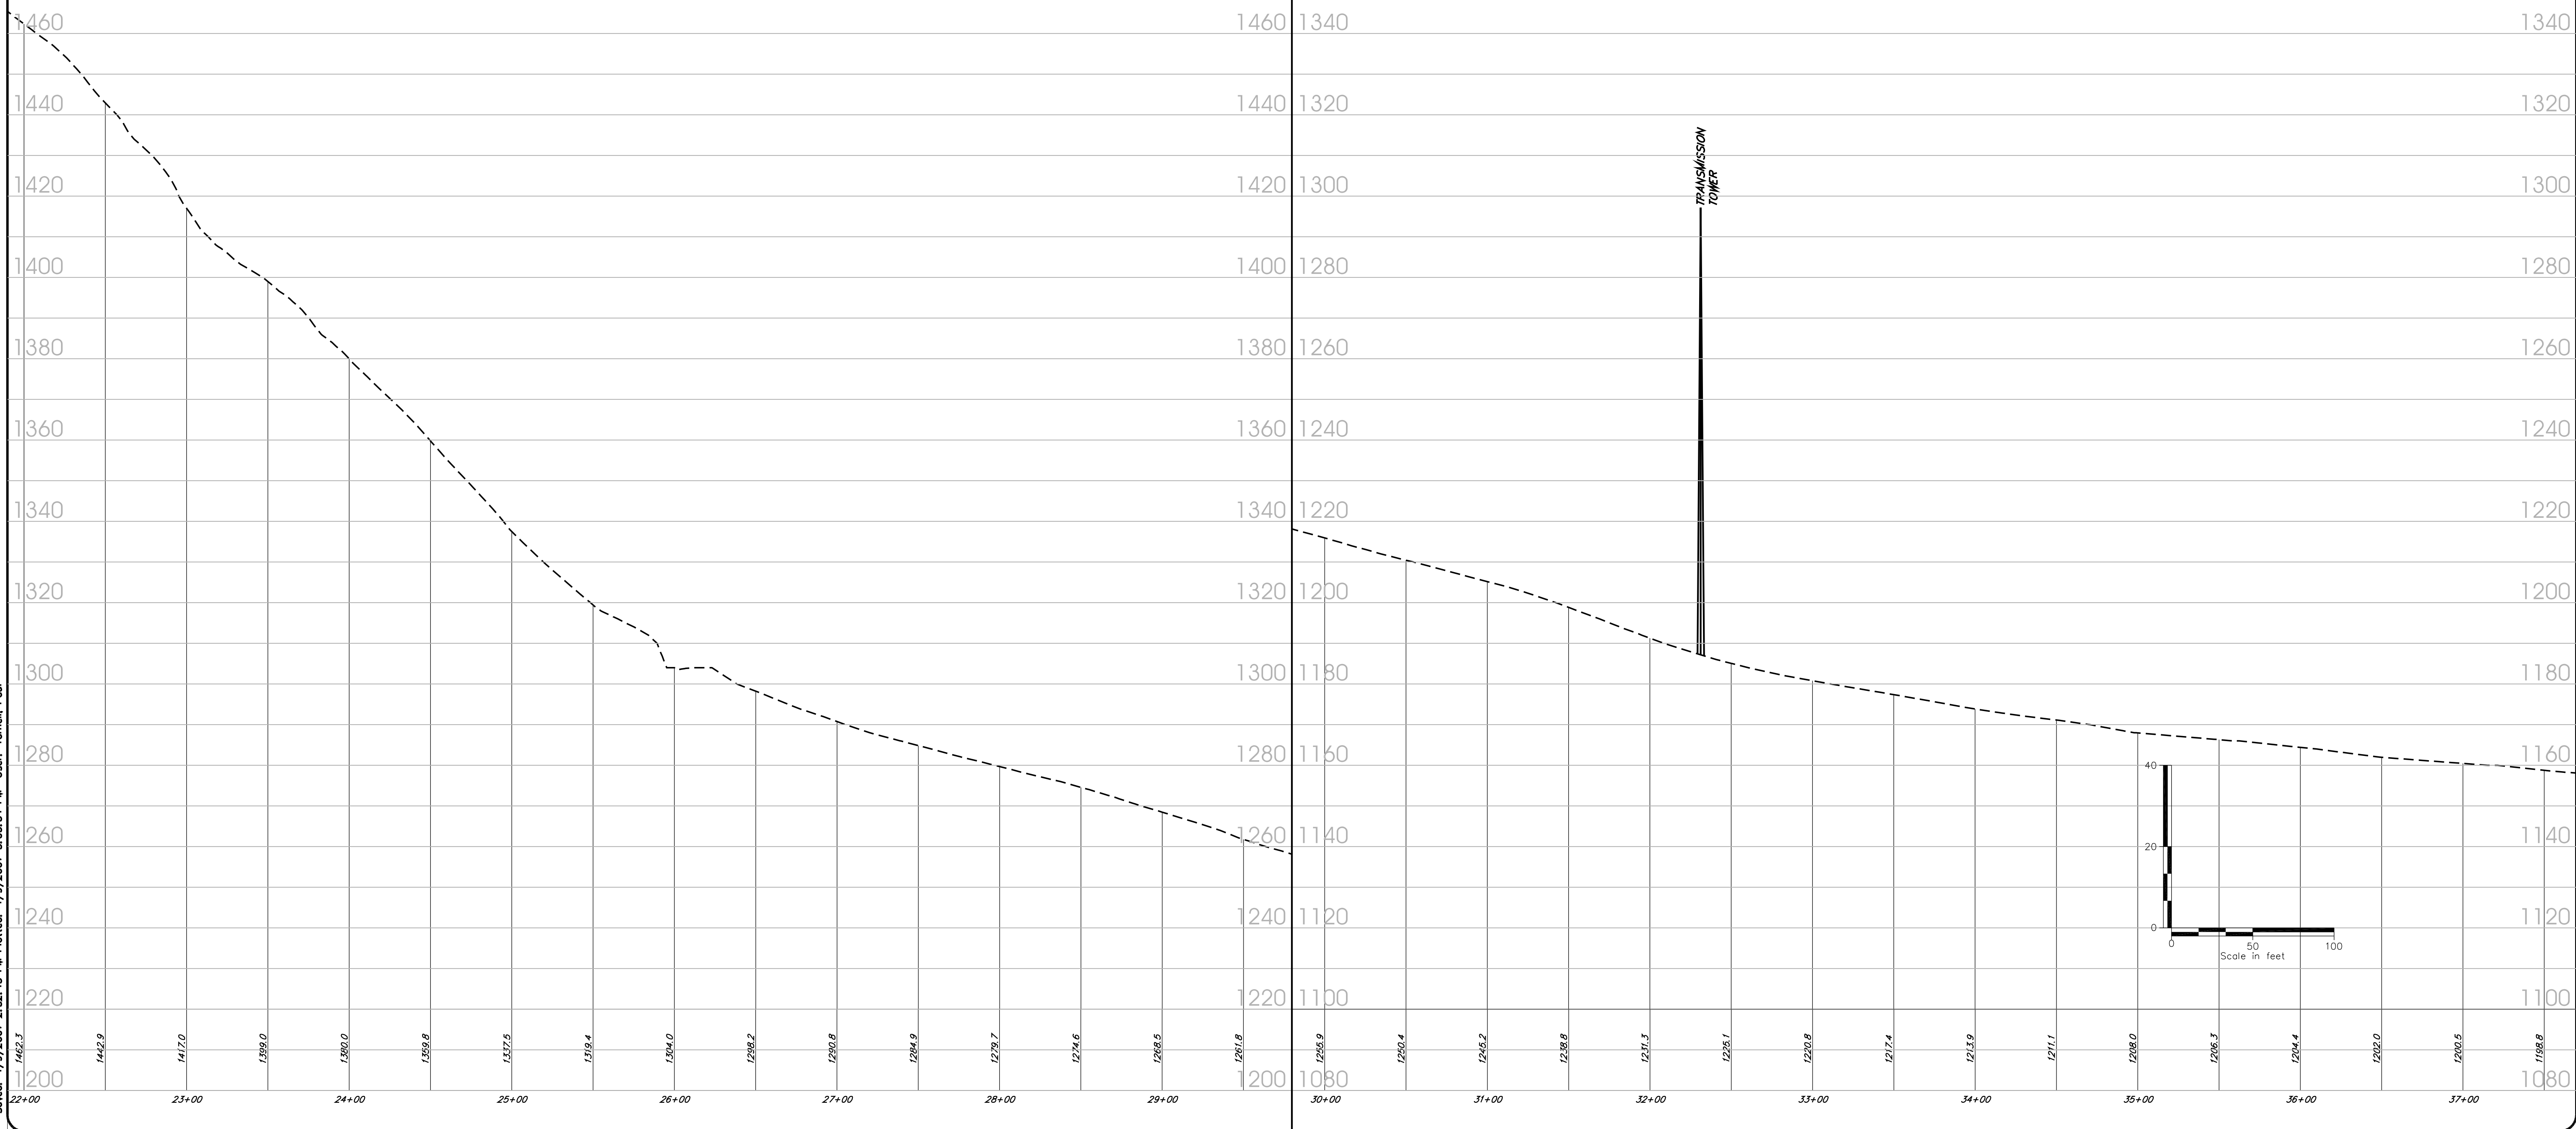



File: I:\15796 - COMMUNITY ENERGY\1101\ACAD\SHRLET_SET\15796_C-284.DWG
 Saved: 4/9/2007 2:52:45 PM Plotted: 4/9/2007 3:03:54 PM User: Yornell, Paul

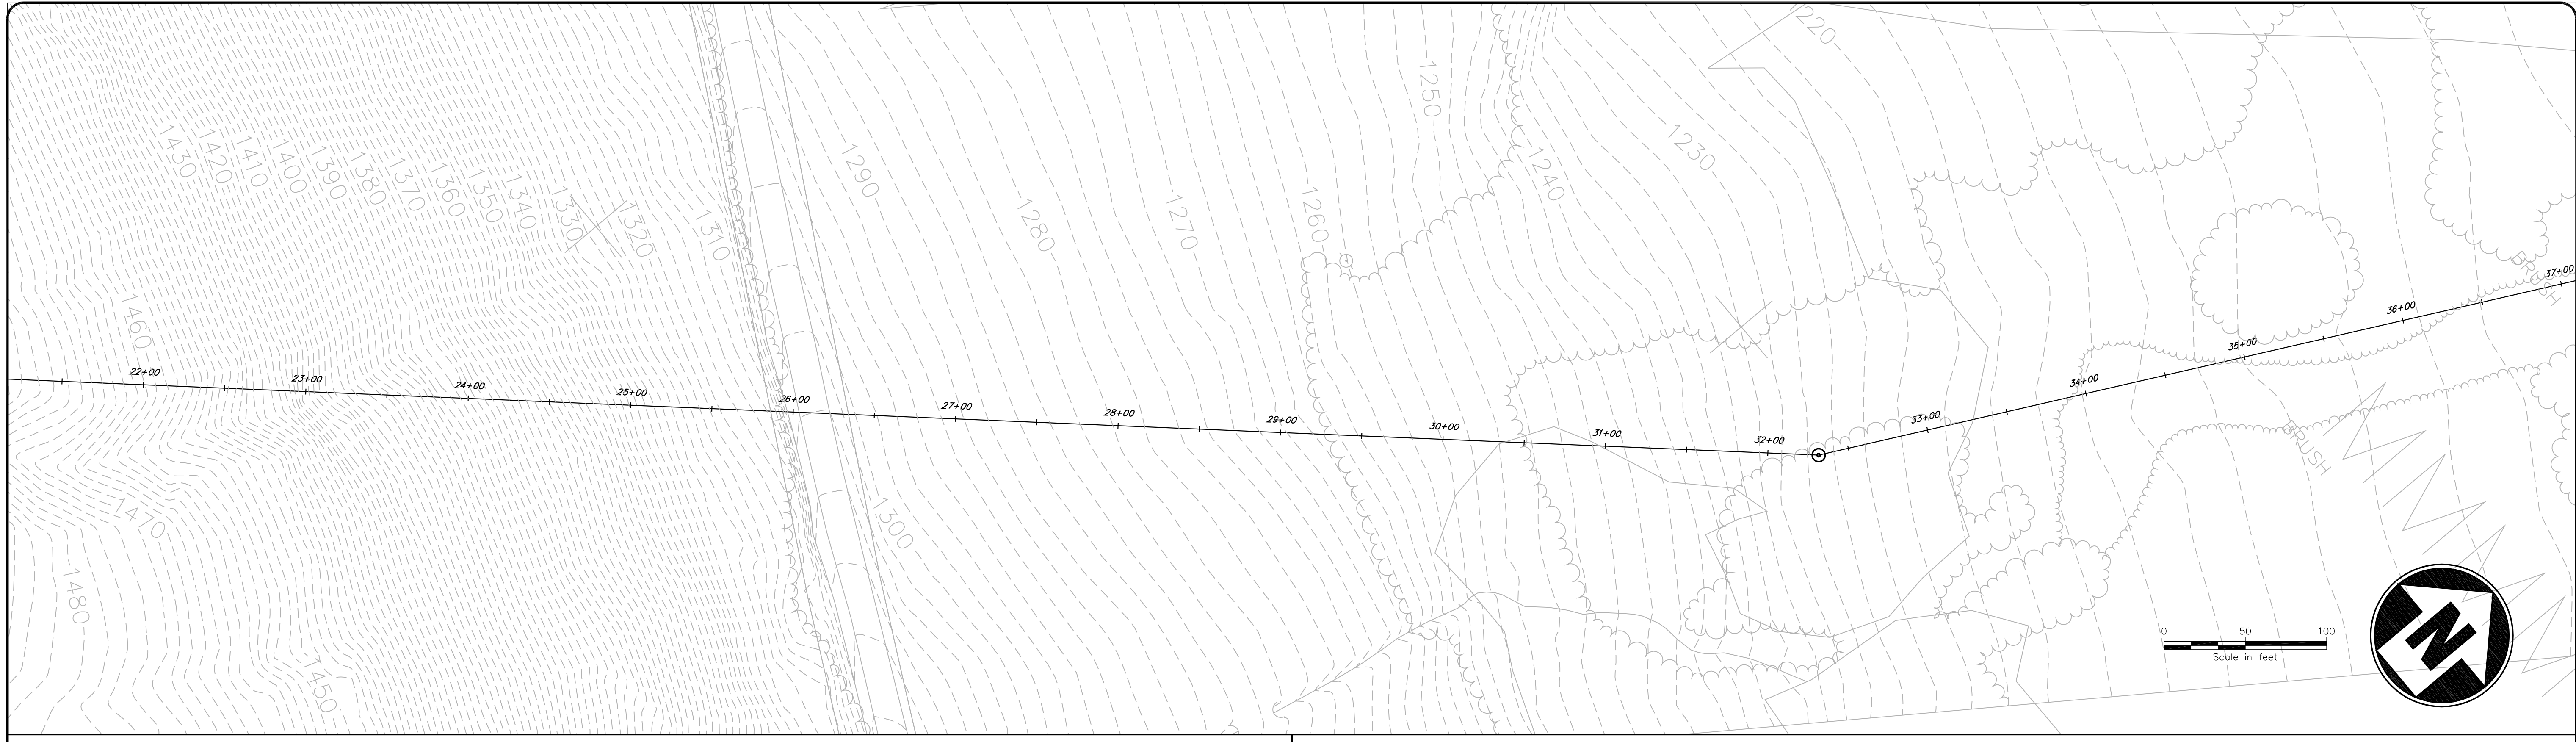

No.	Submitter/Revision	App'd	By	Date

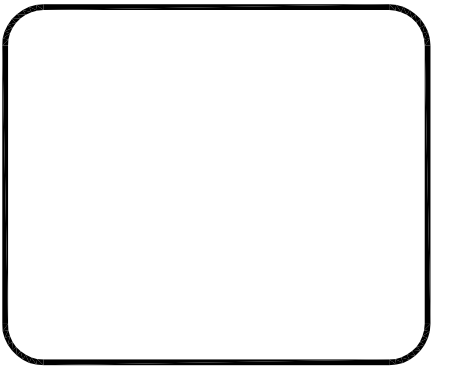

JORDANVILLE WIND, LLC
 480 BROADWAY, SUITE 218
 SARATOGA SPRINGS
 NEW YORK 12866

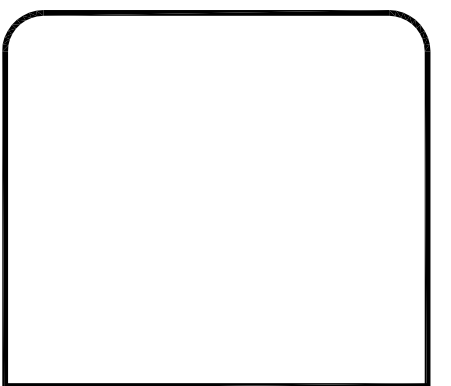

CHA 2005
 CLOUD HARBOR & ASSOCIATES LLP
 100 Main Street, Suite 400
 Saratoga Springs, NY 12866
 www.cha-engineers.com

Designed By: INI	Date: 09.06
Drawn By: INI	Date: 09.06
Checked By: INI	Date: 09.06

UNAUTHORIZED ALTERATION TO THIS DOCUMENT IS A VIOLATION OF FEDERAL, STATE AND/OR LOCAL LAWS.

JORDANVILLE WIND POWER PROJECT
 TOWN OF WARREN/STARK COUNTY OF HERKIMER STATE OF NEW YORK
PLAN AND PROFILE FOR TRANS. LINE FROM COL TO INTER SUBSTATION

Issue Date: 09.28.06 | Project No.: 15796 | Scale: N.T.S.

C-284