

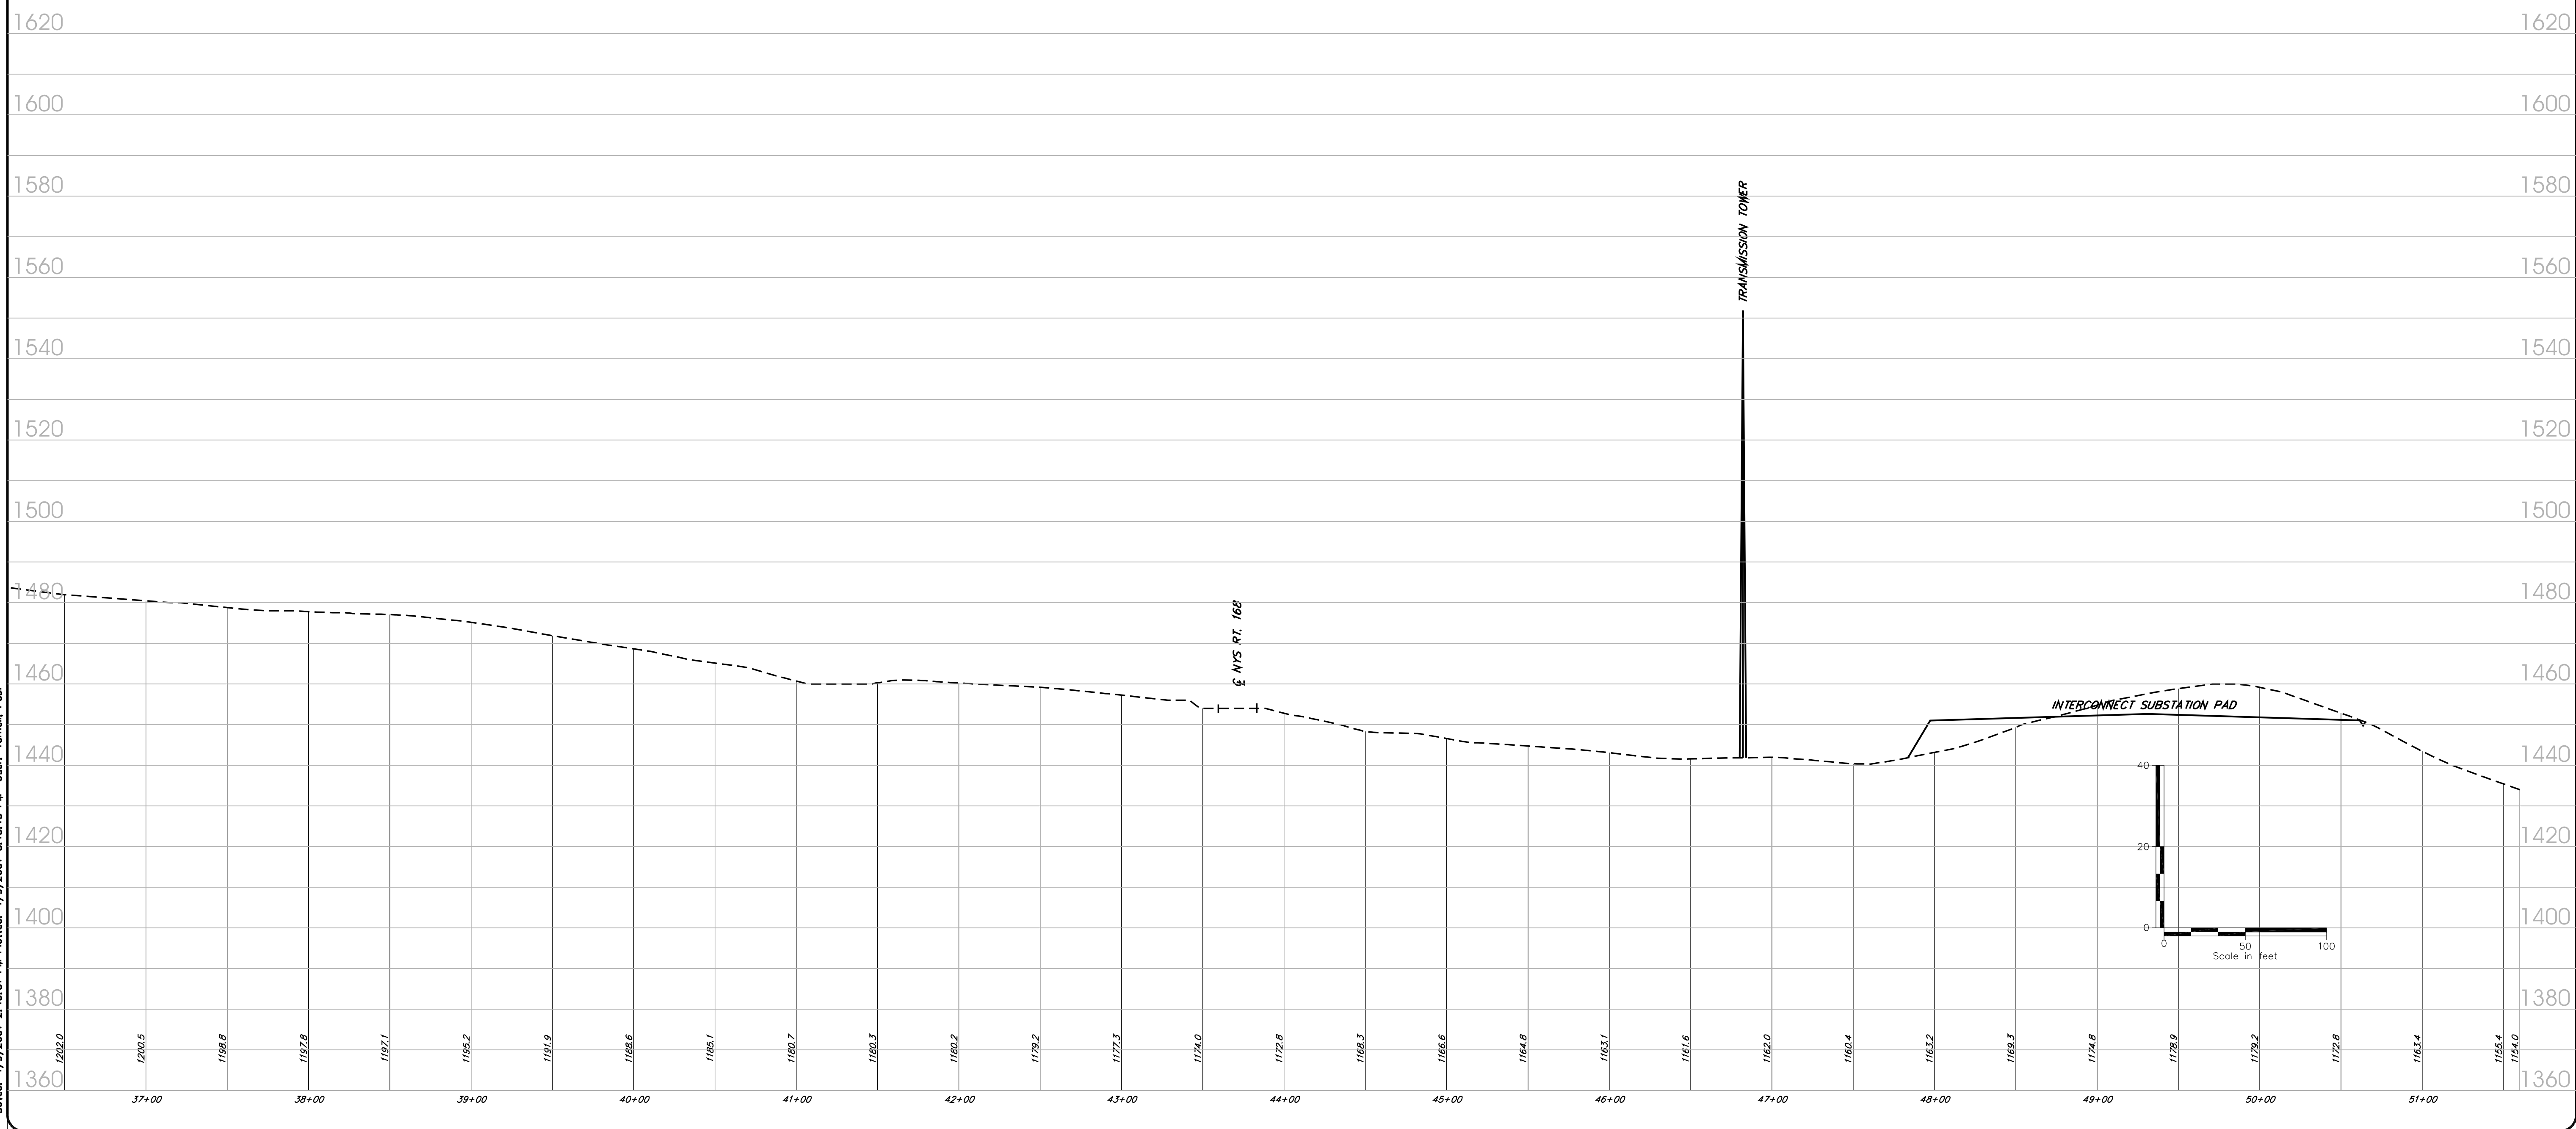



File: I:\15796 - COMMUNITY ENERGY\1101\ACAD\SHRIT_SET\15796_C-285.DWG
 Saved: 4/9/2007 2:46:51 PM Plotted: 4/9/2007 3:15:15 PM User: formel, Paul

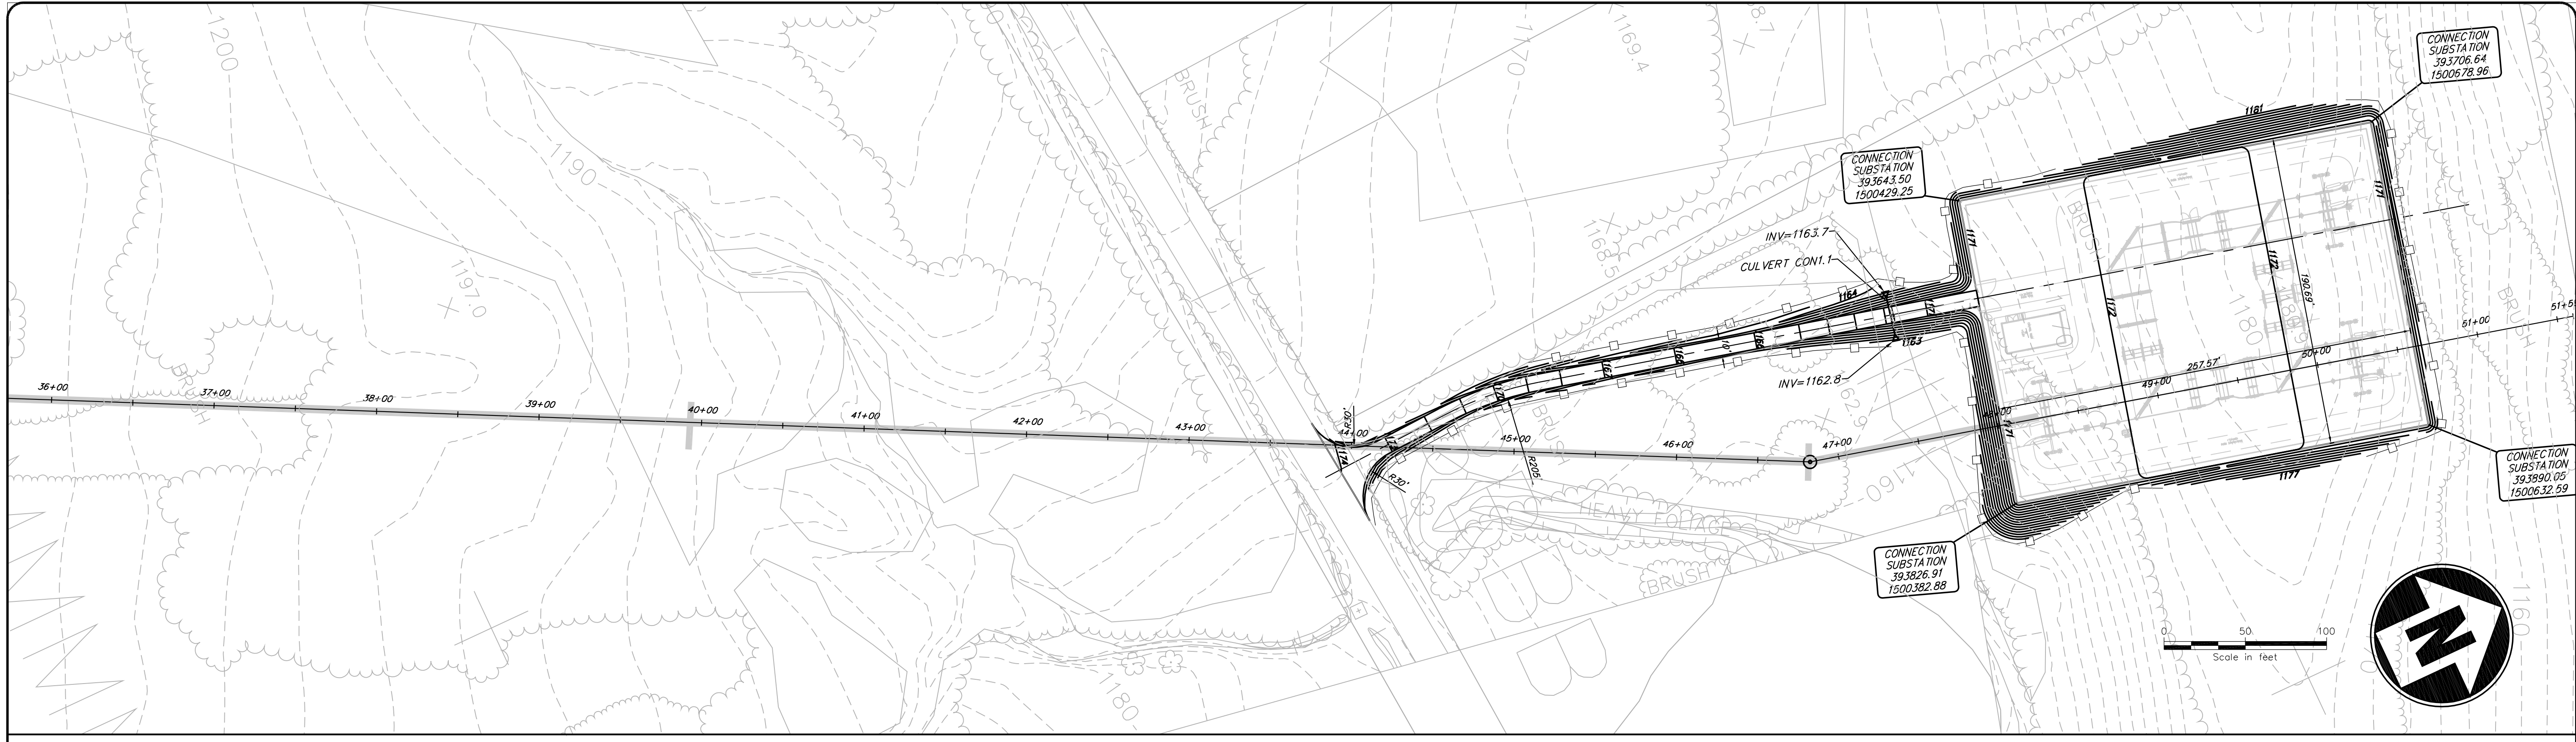

No.	Submitter/Revision	App'd By	Date

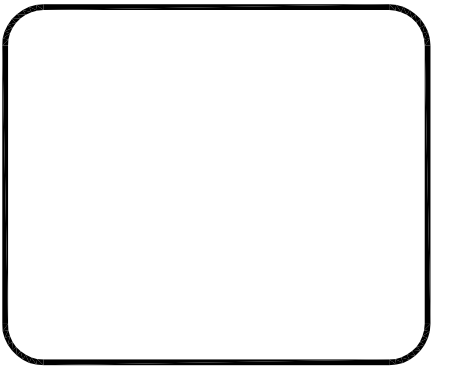

JORDANVILLE WIND, LLC
 480 BROADWAY, SUITE 218
 SARATOGA SPRINGS
 NEW YORK 12866

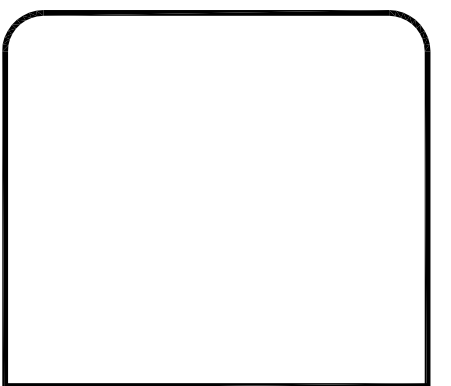

CHA CONSULTING & ASSOCIATES LLP
 1000 WEST 10TH AVENUE, SUITE 200
 DENVER, CO 80202
 TEL: 303.733.1300 FAX: 303.733.1301
 WWW.CHACONLINE.COM

Designed By:	INI	Date:	09.06
Drawn By:	INI	Date:	09.06
Checked By:	INI	Date:	09.06

UNAUTHORIZED ALTERATION TO THIS DOCUMENT IS A VIOLATION OF FEDERAL AND/OR LOCAL LAWS.

JORDANVILLE WIND POWER PROJECT
 TOWN OF WARREN, STARK COUNTY OF HERKIMER STATE OF NEW YORK
PLAN AND PROFILE FOR TRANS. LINE FROM COL TO INTER SUBSTATION
 Issue Date: 09.28.06 | Project No.: 15796 | Scale: N.T.S.

C-285